


SPEC 1

CLASSIC HOME DESIGNS  
 (219) 322-7999  
 While every attempt has been made in preparation of this plan to avoid mistakes, this firm cannot guarantee against human error. Classic Home Designs will not be responsible for the construction site, means, methods, techniques, sequences, or procedures, or for safety precautions and programs in connection with construction; and will not be responsible for contractors failure to carry out the construction in accordance with these plans. The contractor and owner must check all dimensions, details and job site conditions and be responsible for them. Written dimensions on this drawing take precedence over scaled dimensions.

SPEC HOME FOR: KIL - PHARAZIN		DRAWN BY C.D.
SCALE: 1/4" = 1'-0"	APPROVED BY: ✓	REVISED
DATE: 9-7-07		DRAWING NUMBER 1 OF 6
ELEVATIONS		

WINDOW ROUGH-OPENING REFERENCE			
MANUFACT.	UNIT NUMBER	TYPE	ROUGH OPENING
ANDERSEN	C 15	CASEMENT	2'-0" 5/8" x 5'-0" 3/8"
"	C 24	"	4'-0" 1/2" x 4'-0" 1/2"
"	CW 24	"	4'-9" x 4'-0" 1/2"
"	CW 25	"	4'-9" x 5'-0" 3/8"
"	SK 2436	SKYLIGHT	22 1/2" x 36"

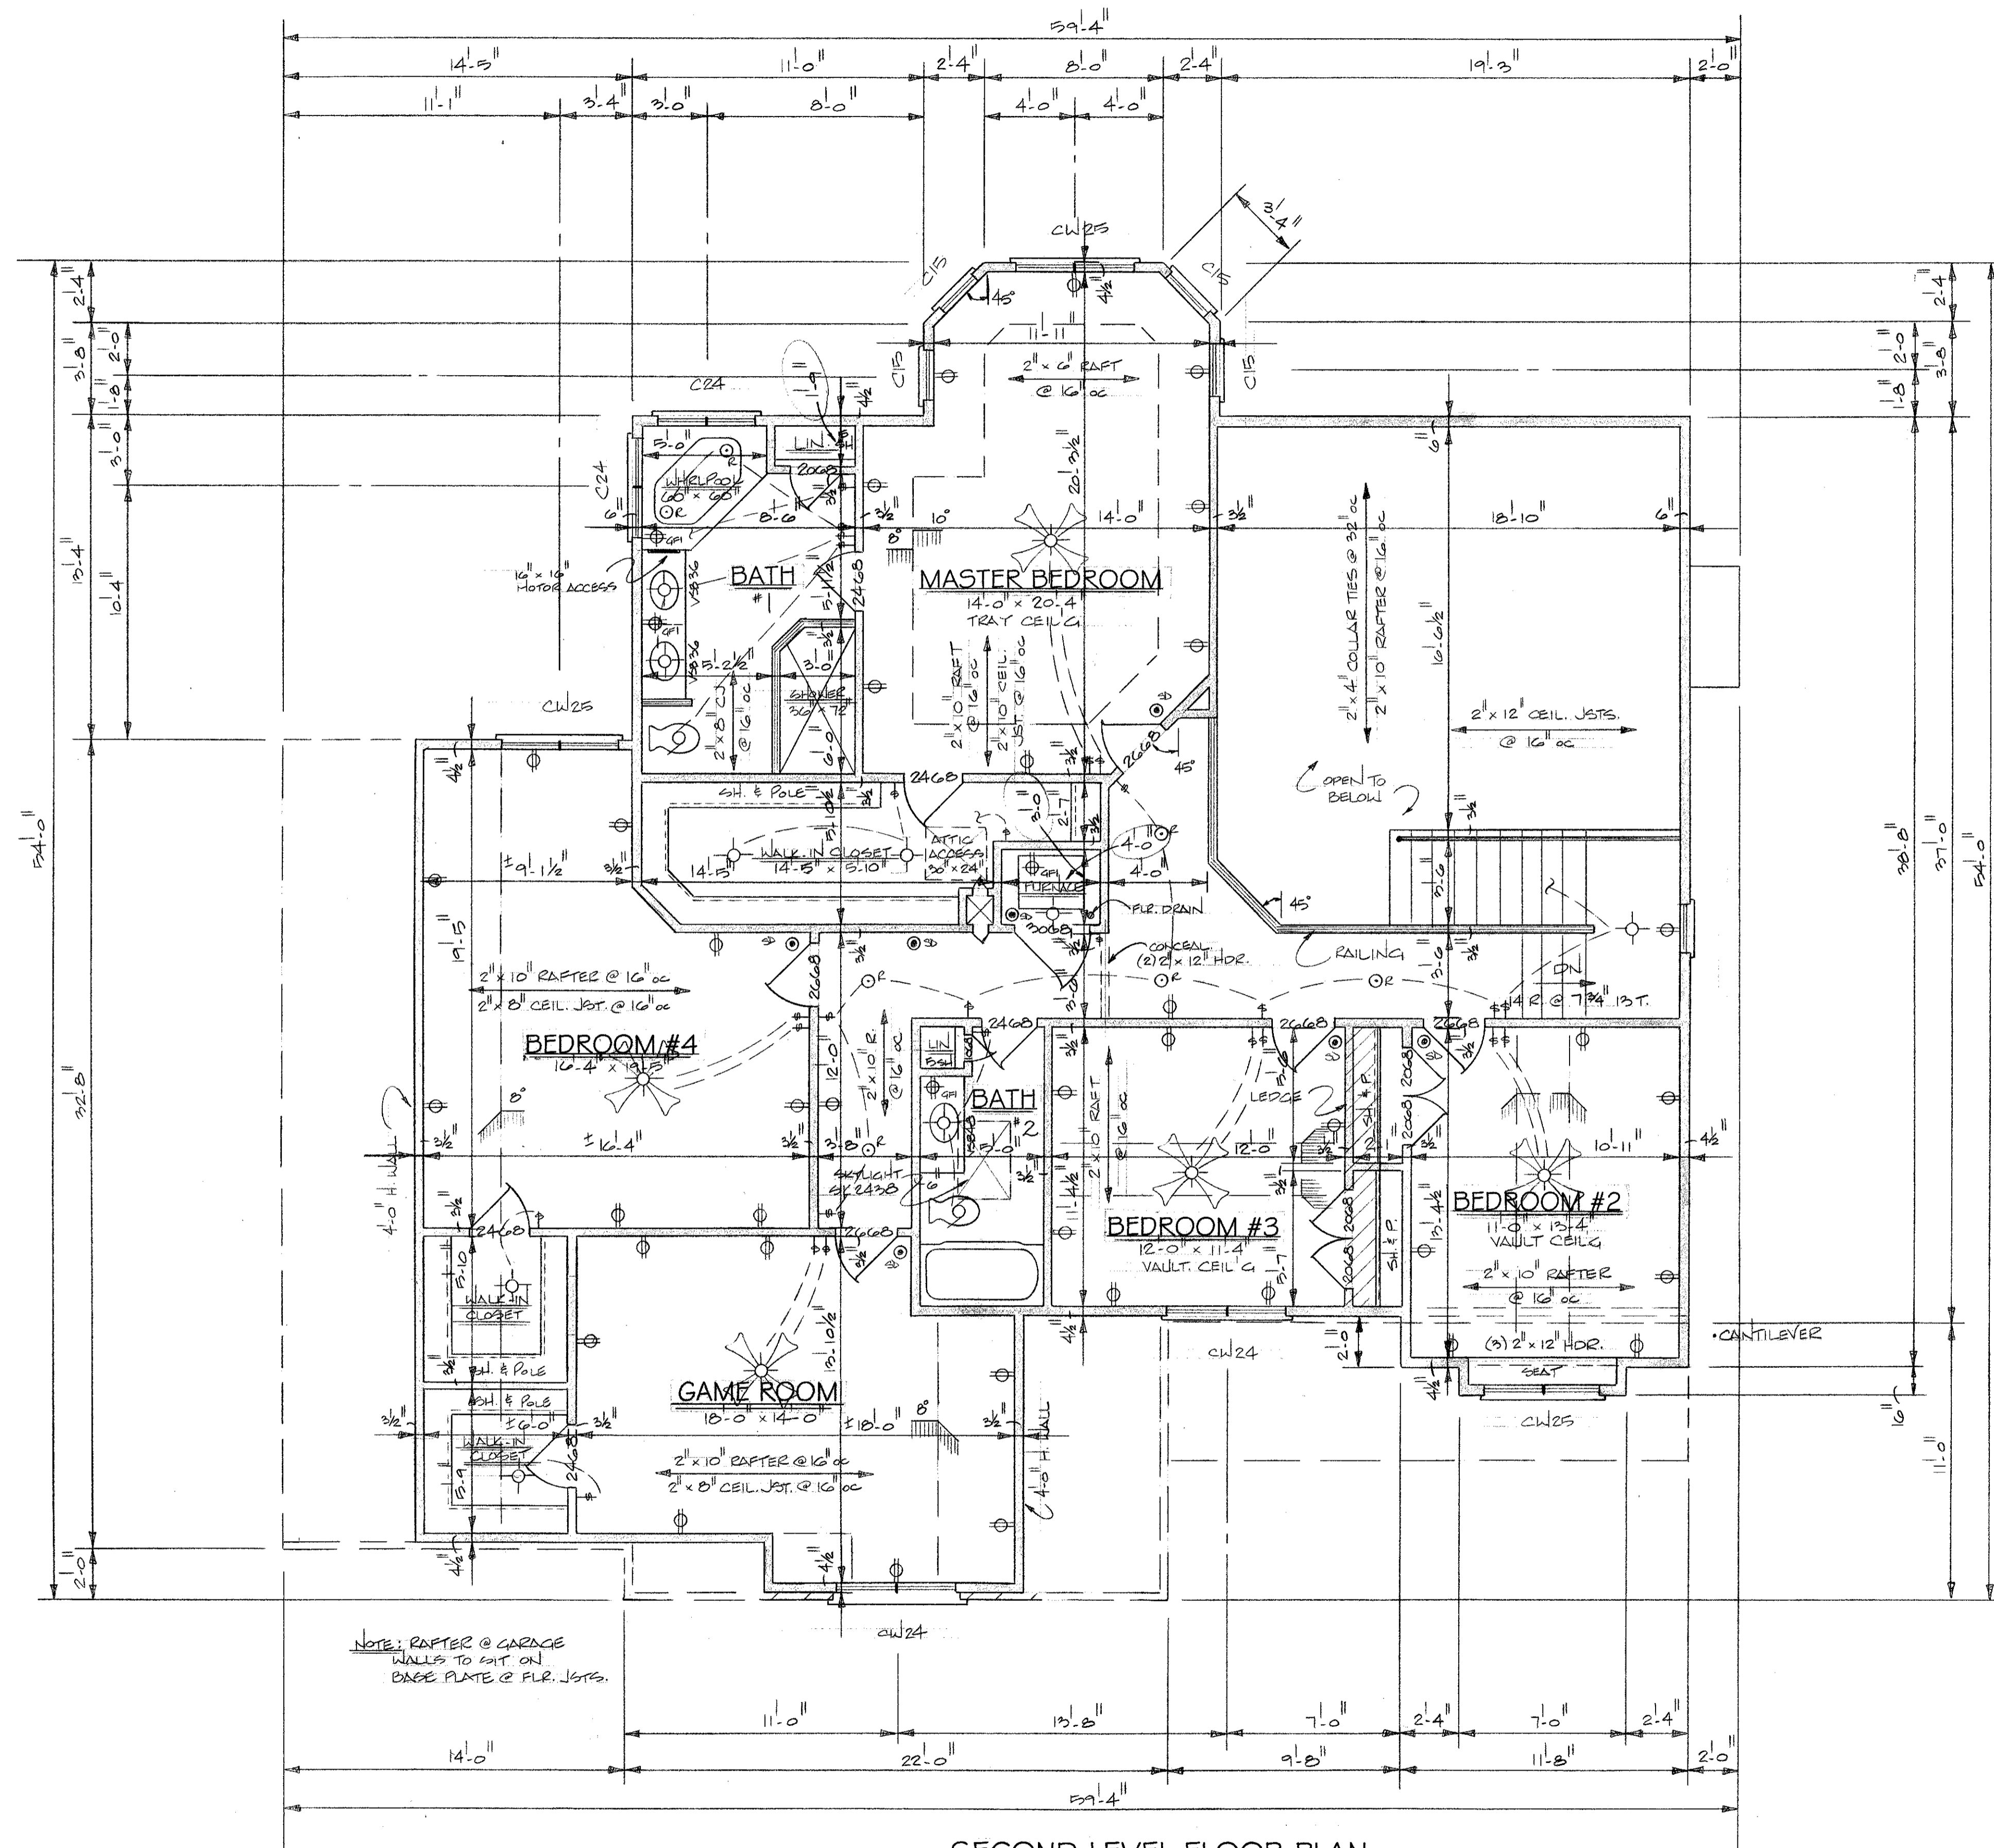

NOTE: RAFTER @ GARAGE WALLS TO EXT. ON BASE PLATE @ FLR. JOSTS.

**SECOND LEVEL FLOOR PLAN**

SCALE: 1/4" = 1'-0"  
 SQ. FT. = 1600 sq ft  
 8'-0" H. WALLS

NOTE:  
 ALL MICRO-LAM BEAMS AND HEADERS TO BE SIZED AND VERIFIED PER ENGINEER.

**HEADER NOTES:**


2" x 6" EXTERIOR WALLS  
 OPENING 6'-0" OR LESS - (2) 2" x 12" HDR.  
 OPENING 6'-1" TO 8'-0" - (3) 2" x 12" HDR.  
 OPENING LARGER THAN 8'-1" - MICRO-LAM BM. HDR.

2" x 4" EXTERIOR WALLS  
 OPENING 6'-0" OR LESS - (2) 2" x 12" HDR.  
 OPENING LARGER THAN 6'-1" - MICRO-LAM BM. HDR.

CLASSIC HOME DESIGNS  
 (219) 322-7999  
 While every attempt has been made in preparation of this plan to avoid mistakes, this firm cannot guarantee against human error. Classic Home Designs will not be responsible for the construction site, means, methods, techniques, sequences, or procedures, or for safety precautions and programs in connection with construction; and will not be responsible for contractors failure to carry out the construction in accordance with these plans. The contractor and owner must check all dimensions, details and job site conditions and be responsible for them. Written dimensions on this drawing take precedence over scaled dimensions.

SPEC HOME FOR: KIL - PHARAZYN		DRAWN BY C.D.
SCALE: 1/4" = 1'-0"	APPROVED BY: [Signature]	REVISION
DATE: 9-7-07	SECOND LVL. FLR. PLAN	
DRAWING NUMBER		6 OF 6

WINDOW ROUGH-OPENING REFERENCE			
MANUFACT.	UNIT NUMBER	TYPE	ROUGH OPENING
ANDERSEN	C 135	CASEMENT	2'-0" 5/8" x 3'-5" 3/8"
"	C 15	"	2'-0" 5/8" x 5'-0" 3/8"
"	C 235	"	4'-0" 1/2" x 3'-5" 3/8"
"	C 25	"	4'-0" 1/2" x 5'-0" 3/8"
"	CW 25	"	4'-9" x 5'-0" 3/8"
"	P 4050	PICTURE	4'-0" 1/2" x 5'-0" 3/8"
"	AFC 25	SPRINGLINE	4'-0" 1/2" x 5'-6" 5/16"
"	FWG 6068	FRENCH SLIDER	6'-0" x 6'-8"
THERMATRU	210	DOOR	6'-1" 5/8" x 6'-10" 1/2"
PER OWNER	3068 w/2-14" sill	"	5'-9" 1/2" x 6'-10" 1/2"

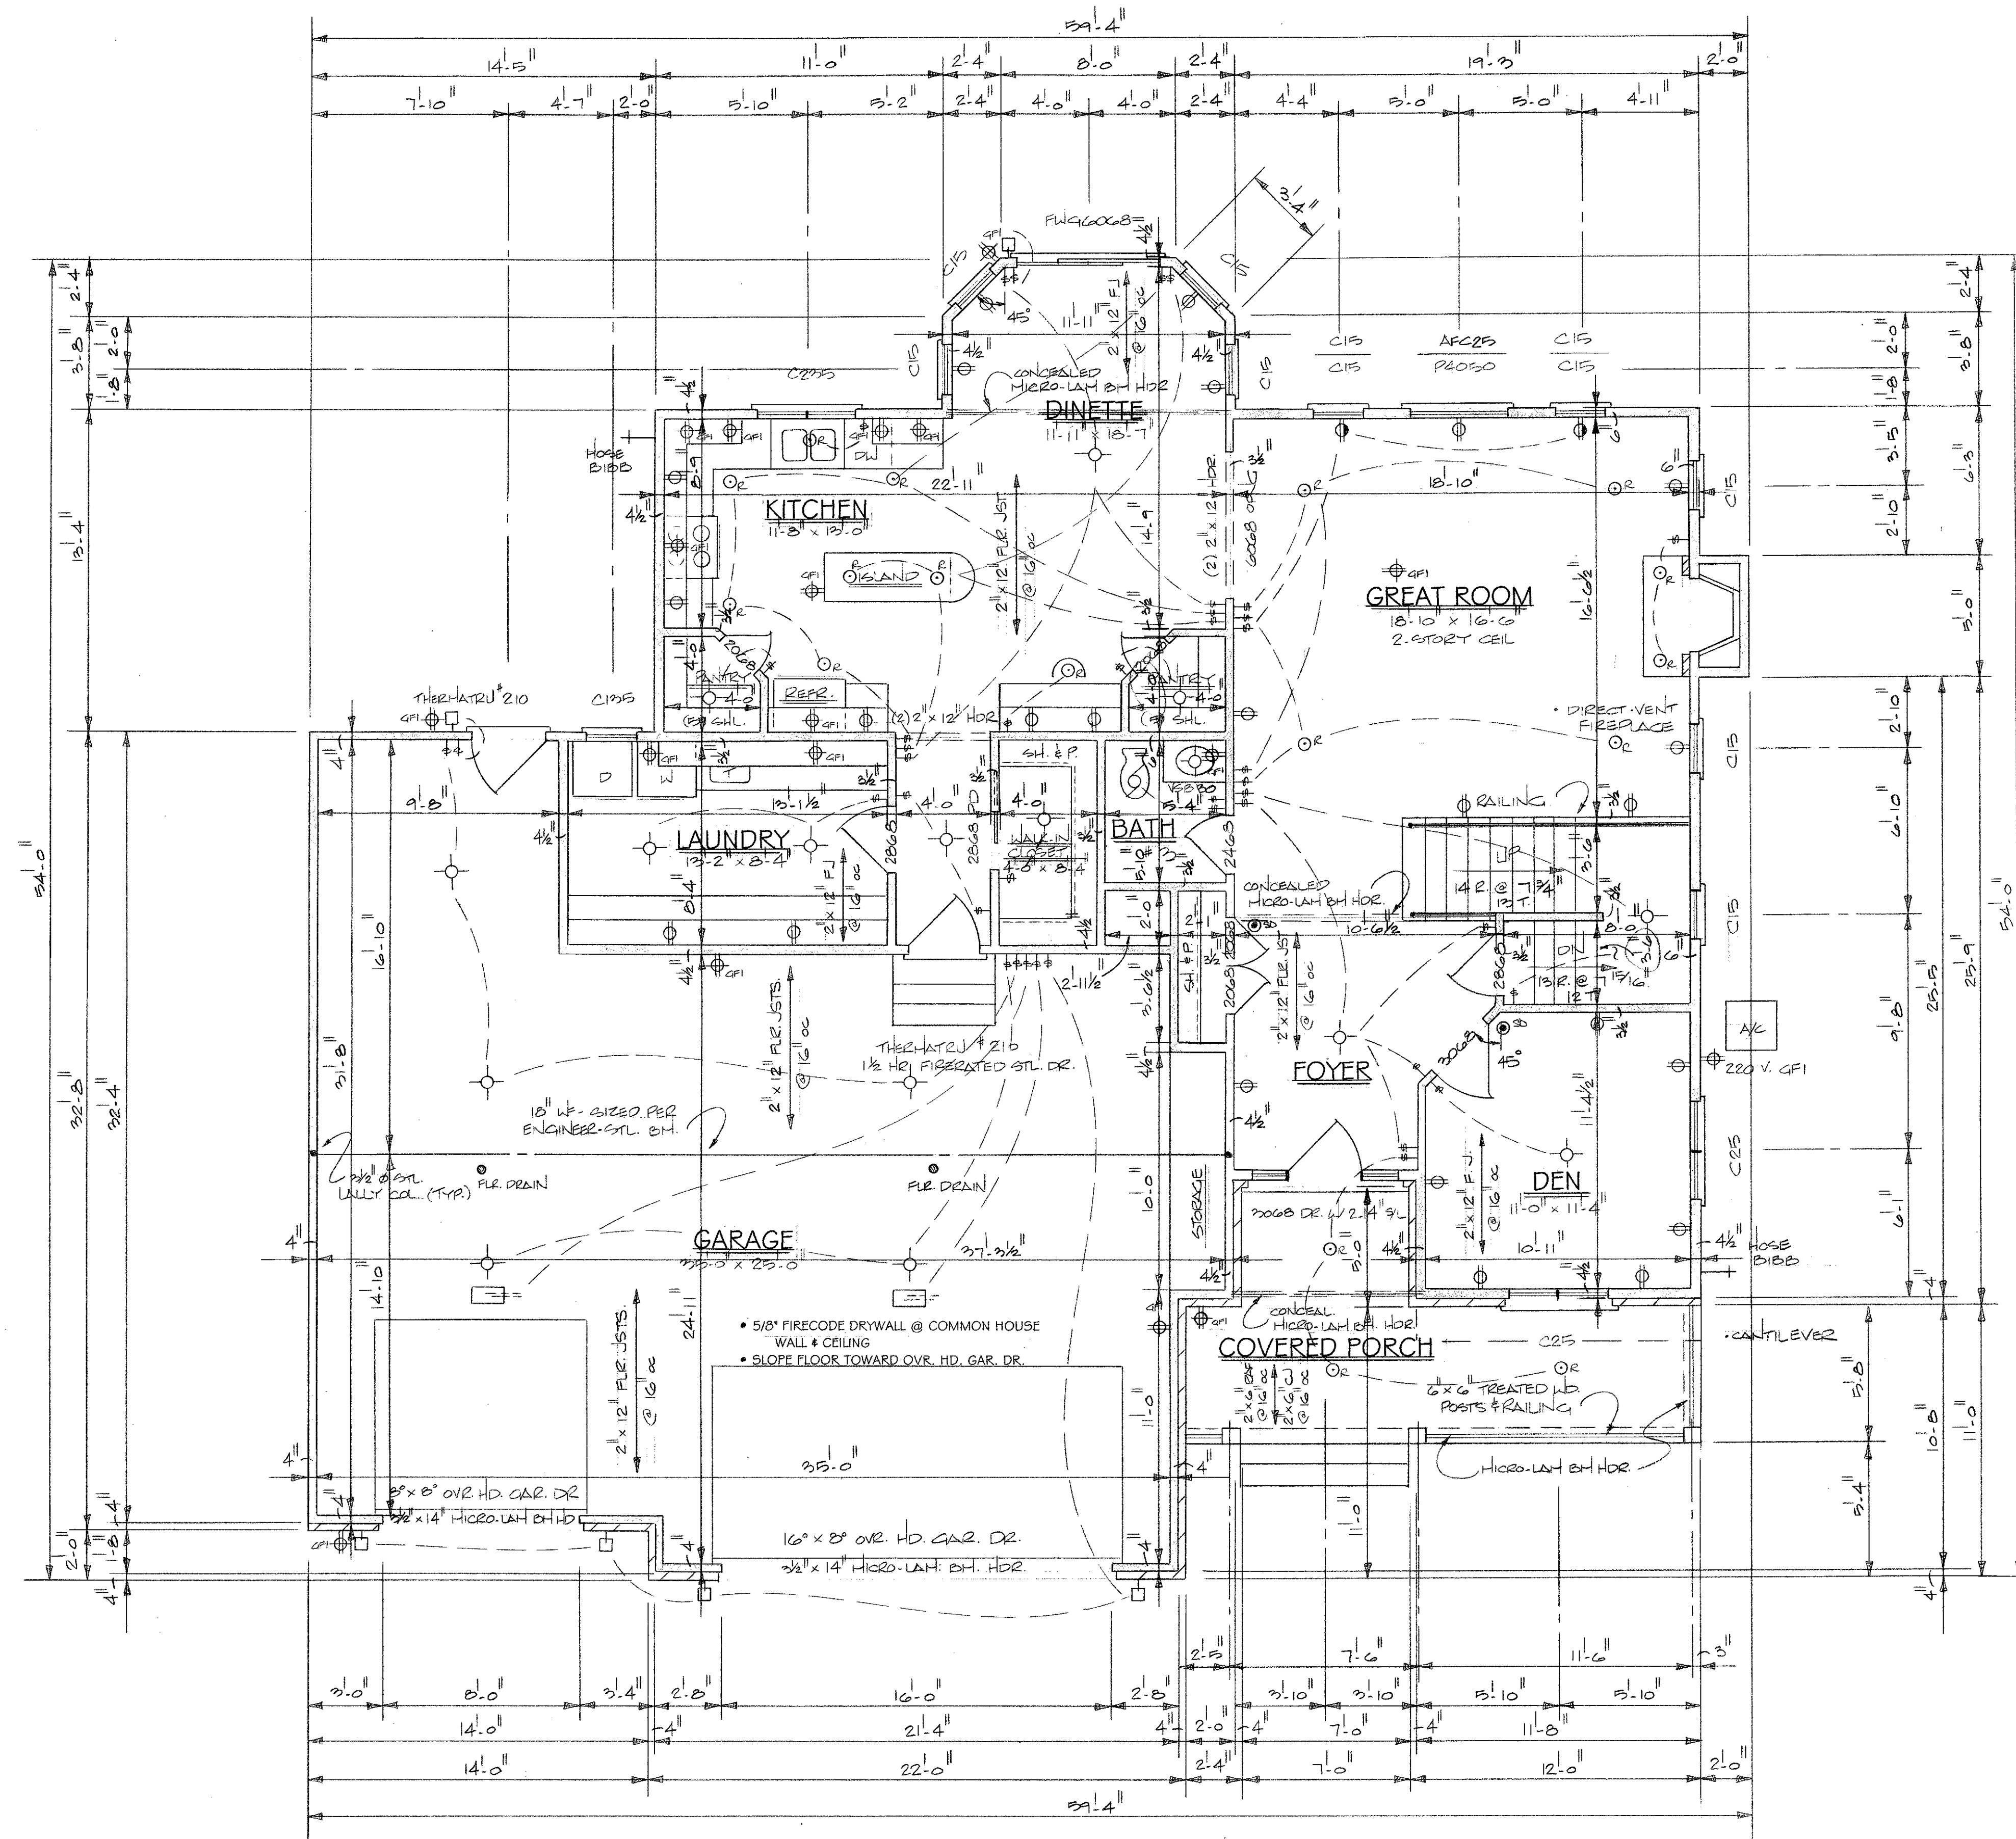

- ELECTRICAL LEGEND**
- Ceiling Mounted Light Fixture
  - ⊕ Duplex Receptacle
  - ⬆ Wall Switch
  - ⊙ Smoke Detector
  - ⊠ Exterior Wall Mounted Light Fixture
  - ⊞ Garage Door Opener With Light
  - ⊗ Recessed Can Light Fixture
  - ⊕ G.F.I. Ground Fault Interrupter
  - ⊕ Full Cham With Receptacle Outlet
  - ⊕ Exhaust Fan - See Note #1

- Electrical Notes:**
1. All exhaust fans shall be vented to outside.
  2. Smoke Detector: Actuation of one actuates all.
  3. Carbon Monoxide Detector: Locate one per floor.

FIRST FLR. SQ. FT. = 1304 #  
 SECOND FLR. SQ. FT. = 1603 #  
 TOTAL SQ. FT. = 2907 #

**FIRST LEVEL FLOOR PLAN**  
 SCALE: 1/4" = 1' - 0"  
 SQ. FT. = 1304 #  
 8'-0" H. WALLS

**NOTE:**  
 ALL MICRO-LAM BEAMS AND HEADERS TO BE SIZED AND VERIFIED PER ENGINEER.

- HEADER NOTES:**
- 2" x 6" EXTERIOR WALLS  
 OPENING 6'-0" OR LESS - (2) 2" x 12" HDR.  
 OPENING 6'-1" TO 8'-0" - (3) 2" x 12" HDR.  
 OPENING LARGER THAN 8'-1" - MICRO-LAM BM. HDR.
  - 2" x 4" EXTERIOR WALLS  
 OPENING 6'-0" OR LESS - (2) 2" x 12" HDR.  
 OPENING LARGER THAN 6'-1" - MICRO-LAM BM. HDR.


CLASSIC HOME DESIGNS  
 (219) 322-7999  
 While every attempt has been made in preparation of this plan to avoid mistakes, this firm cannot guarantee against human error. Classic Home Designs will not be responsible for the construction site, means, methods, techniques, sequences, or procedures, or for safety precautions and programs in connection with construction; and will not be responsible for contractors failure to carry out the construction in accordance with these plans. The contractor and owner must check all dimensions, details and job site conditions and be responsible for them. Written dimensions on this drawing take precedence over scaled dimensions.

**SPEC HOME FOR:**  
 KIL - PHARAZIN

SCALE: 1/4" = 1'-0"    APPROVED BY: ✓    DRAWN BY: C.O.  
 DATE: 9-7-07    REVISIONS:

FIRST WL. FLR. PLAN    DRAWING NUMBER: 3 OF 4


WINDOW ROUGH-OPENING REFERENCE			
MANUFACT.	UNIT NUMBER	TYPE	ROUGH OPENING
ANDERSEN	2013	BASEMENT SASH	2'-0 5/8" x 1'-3 1/4"

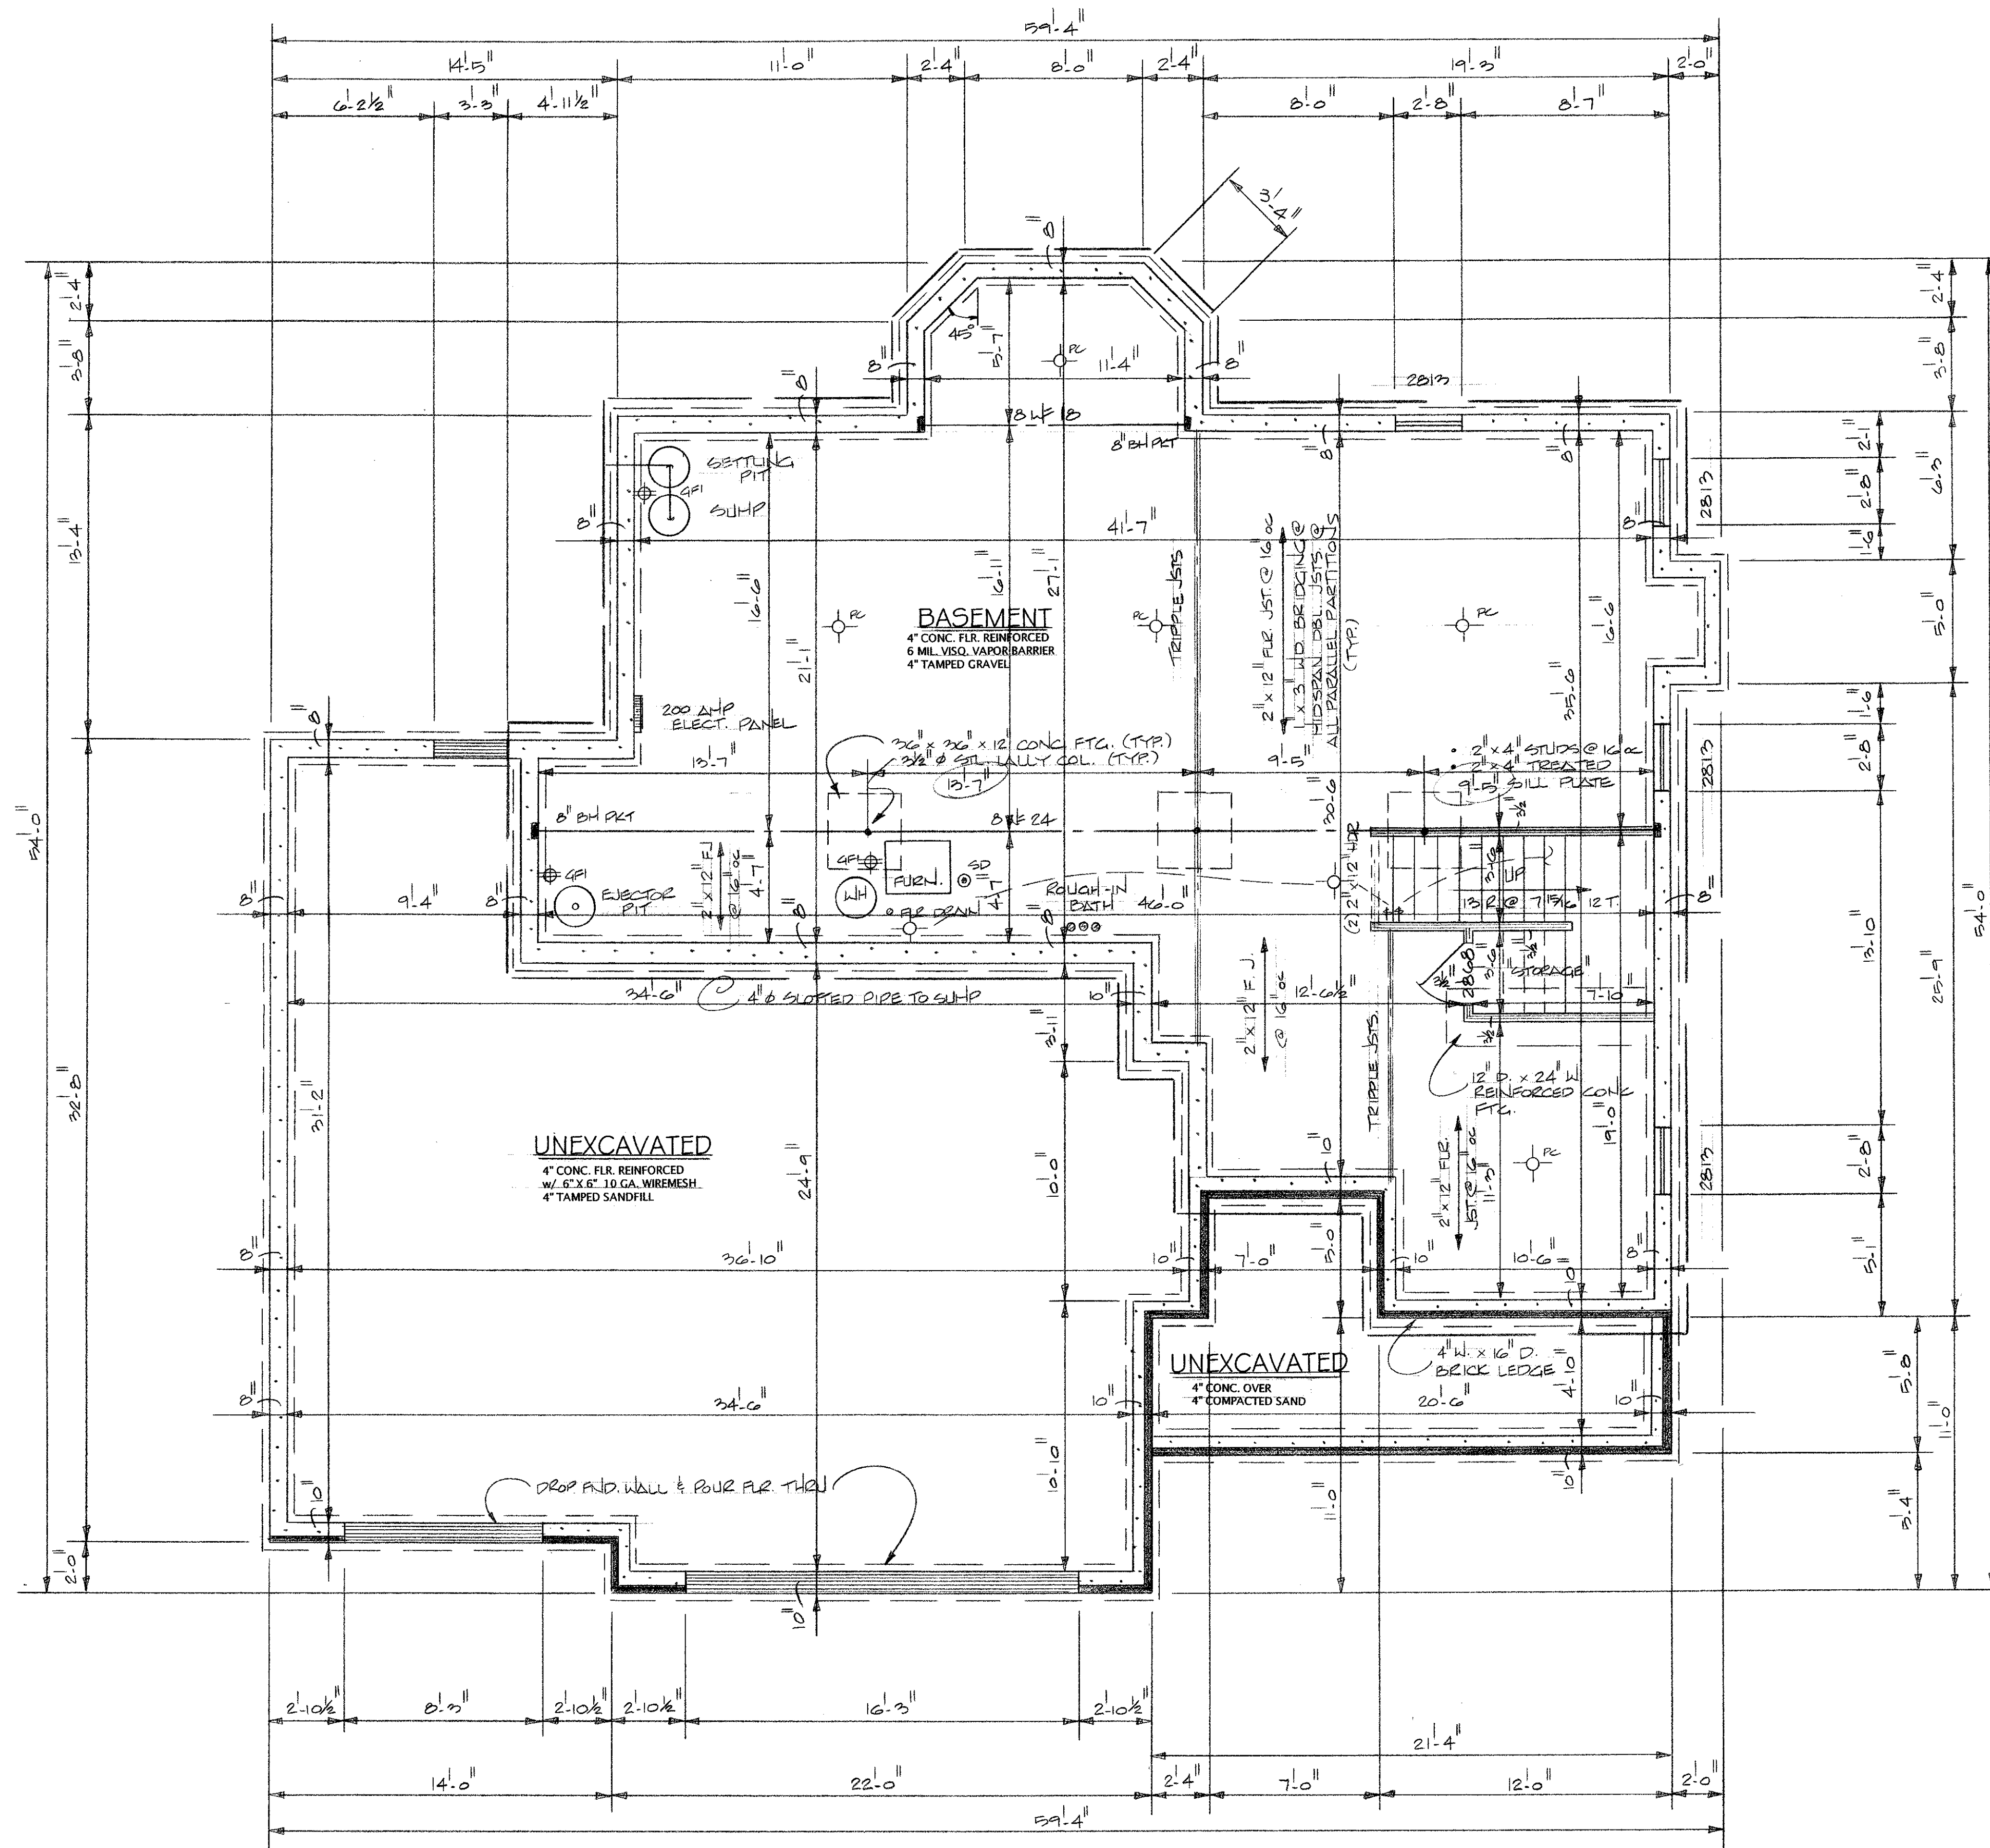

**FOUNDATION PLAN**  
SCALE: 1/4" = 1'-0"

CLASSIC HOME DESIGNS  
(213) 322-7999  
While every attempt has been made in preparation of this plan to avoid mistakes, the firm cannot guarantee against human error. Classic Home Designs will not be responsible for the construction site, means, methods, techniques, sequences, or procedures, or for safety precautions and programs in connection with construction; and will not be responsible for contractors failure to carry out the construction in accordance with these plans. The contractor and owner must check all dimensions, details and job site conditions and be responsible for them. Written dimensions on the drawing take precedence over scaled dimensions.

SPEC HOME FOR: KIL - PHARAZIN			
SCALE: 1/4" = 1'-0"	APPROVED BY: ✓	DRAWN BY: C.D.	
DATE: 9-7-07		REVISED:	
FOUNDATION PLAN			
			DRAWING NUMBER 4 OF 6

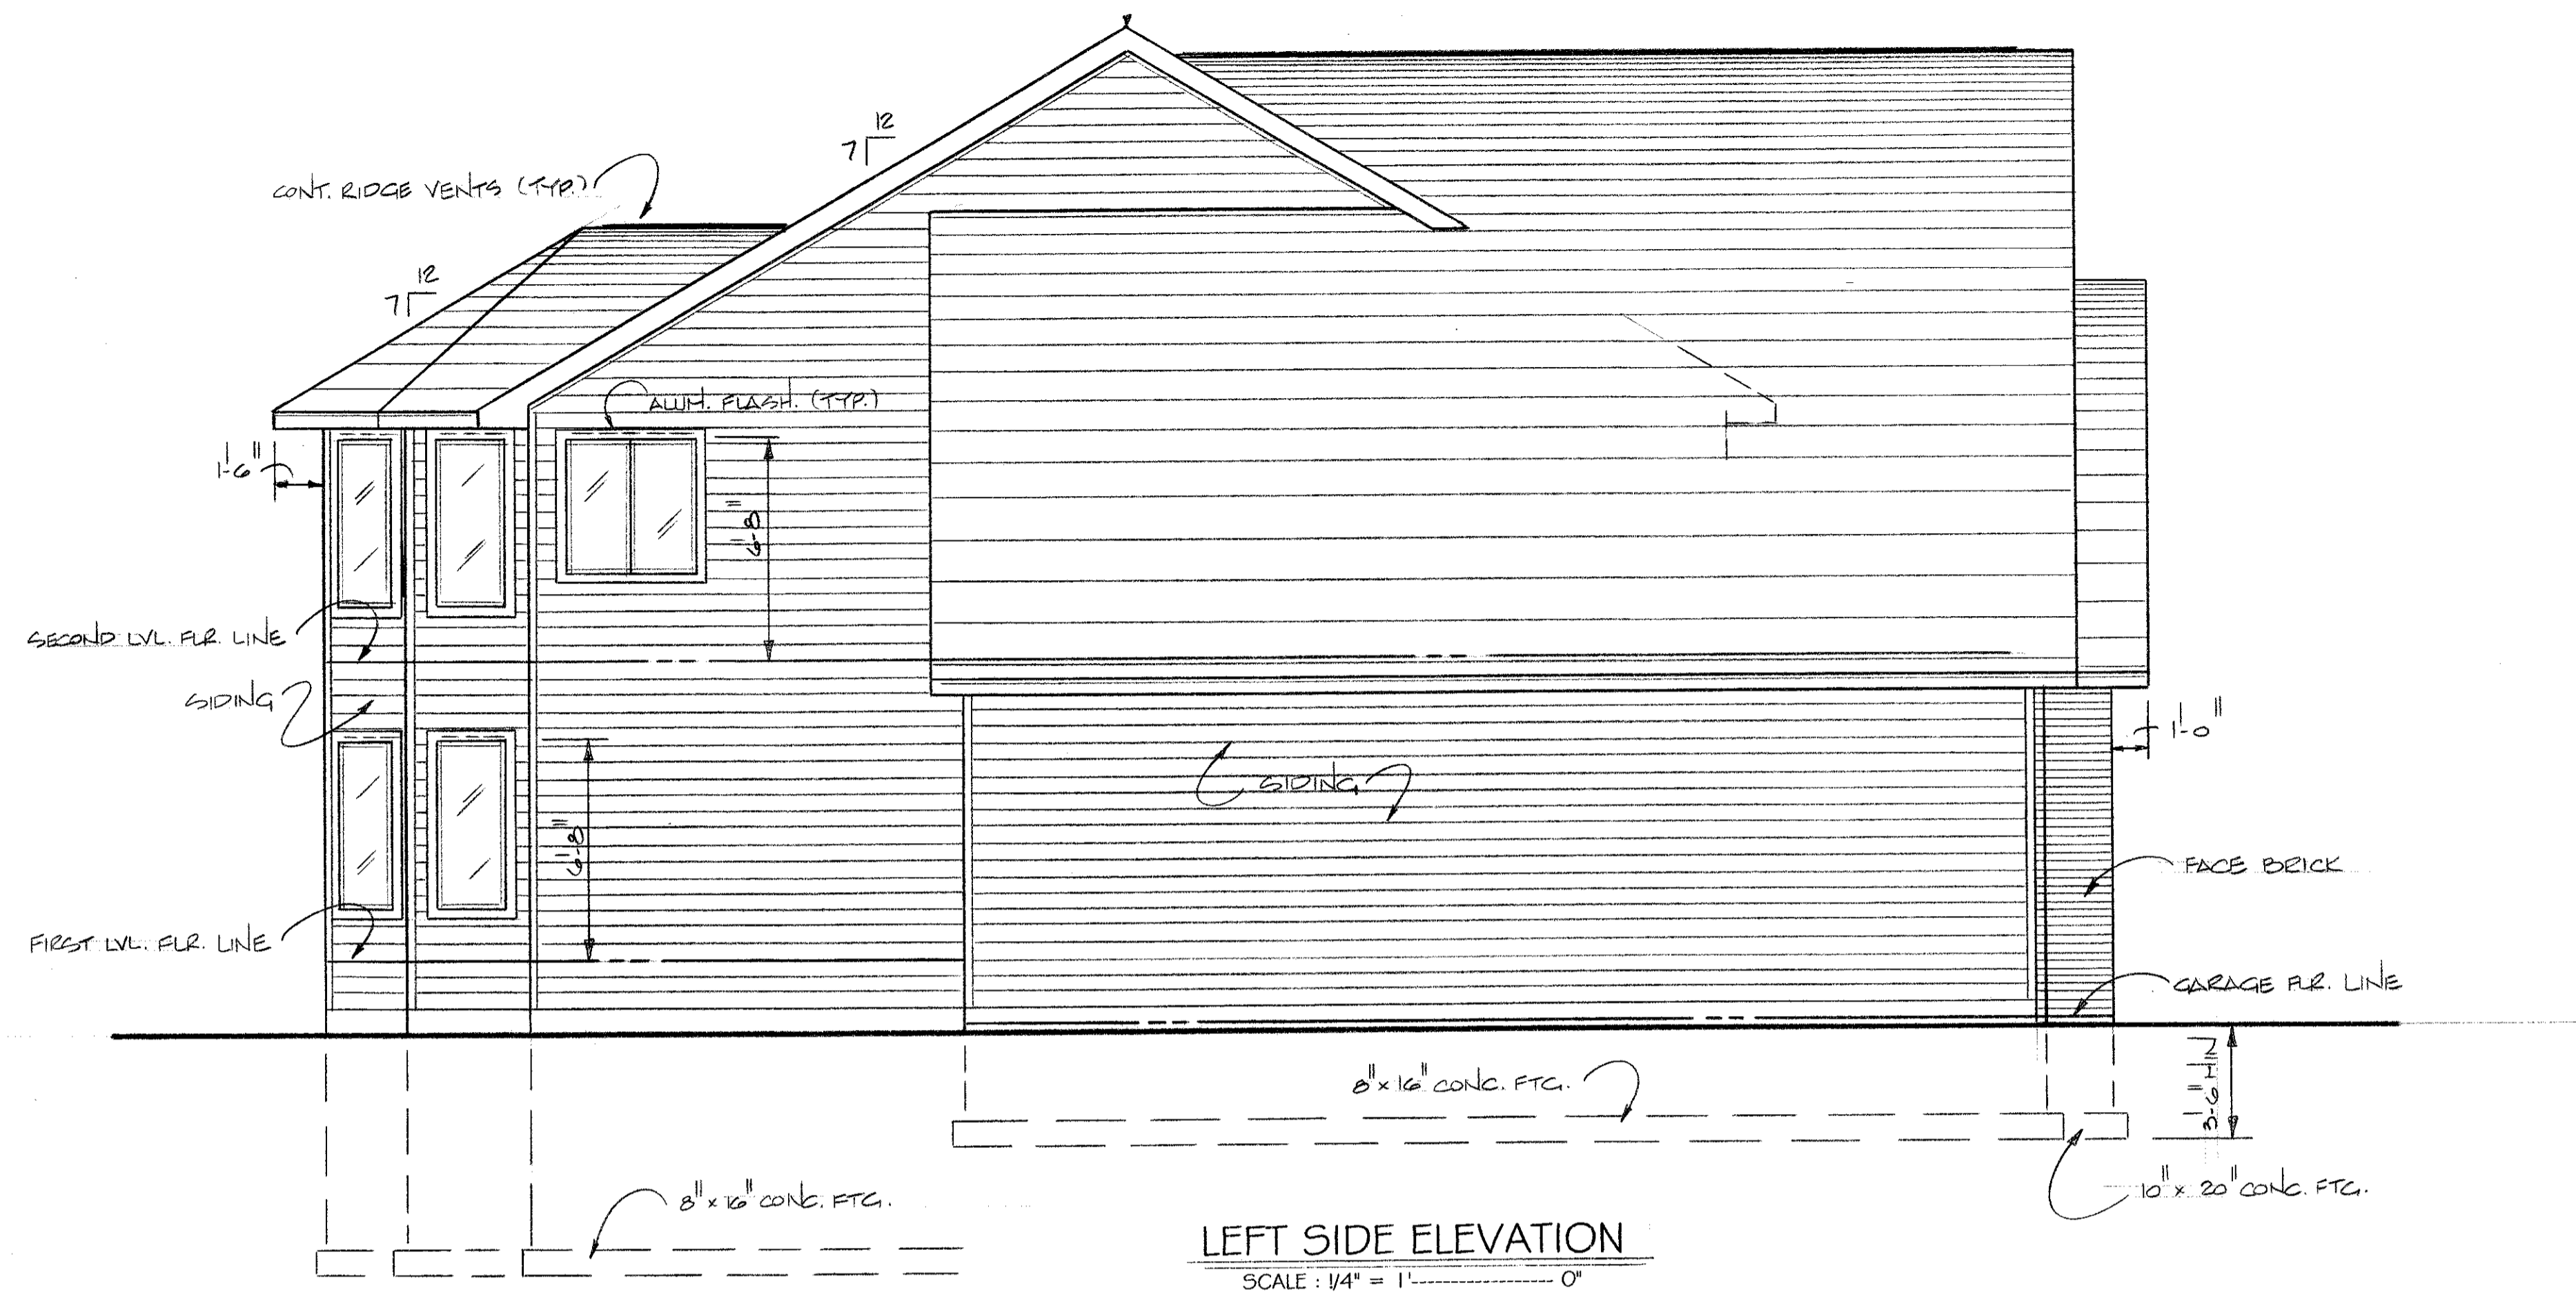

CLASSIC HOME DESIGNS  
 (219) 322-7999  
 While every attempt has been made in preparation of this plan to avoid mistakes, this firm cannot guarantee against human error. Classic Home Designs will not be responsible for the construction site, means, methods, techniques, sequences, or procedures, or for safety precautions and programs in connection with construction, and will not be responsible for contractors failure to carry out the construction in accordance with these plans. The contractor and owner must check all dimensions, details and job site conditions and be responsible for them. Written dimensions on this drawing take precedence over scaled dimensions.

SPEC HOME FOR: KIL - PHARAZYN		DRAWN BY C.D.
SCALE: 1/4" = 1'-0"	APPROVED BY: /	REVISED
DATE: 7-7-07	ELEVATIONS	
DRAWING NUMBER 2 OF 6		